

OVERSTREET DRILL SITE
GHA BARNETT, LLC.
DRILL SITE PLAN
MANSFIELD, TEXAS


PROJECT TITLE:
OVERSTREET DRILL SITE
GHA BARNETT, LLC.

4414 W. Loop West, Suite 100, Houston, Texas 77056
800 W. Main Street
Mansfield, Texas 76063
817-480-2611
FAX: 817-480-8700
WWW.MLMJA.COM

PROJECT NUMBER: 2008-00-18
PROJECT MANAGER: J. BLUMFELT
DRAWN BY: M. YOUNG
CHECKED BY: A. GARDNER
DATE: 12/12/2012

REV. DATE DESCRIPTION BY
SHEET CONTENT:

SHEET NO. 1
COPYRIGHT © 2012 MLMJA, INC.

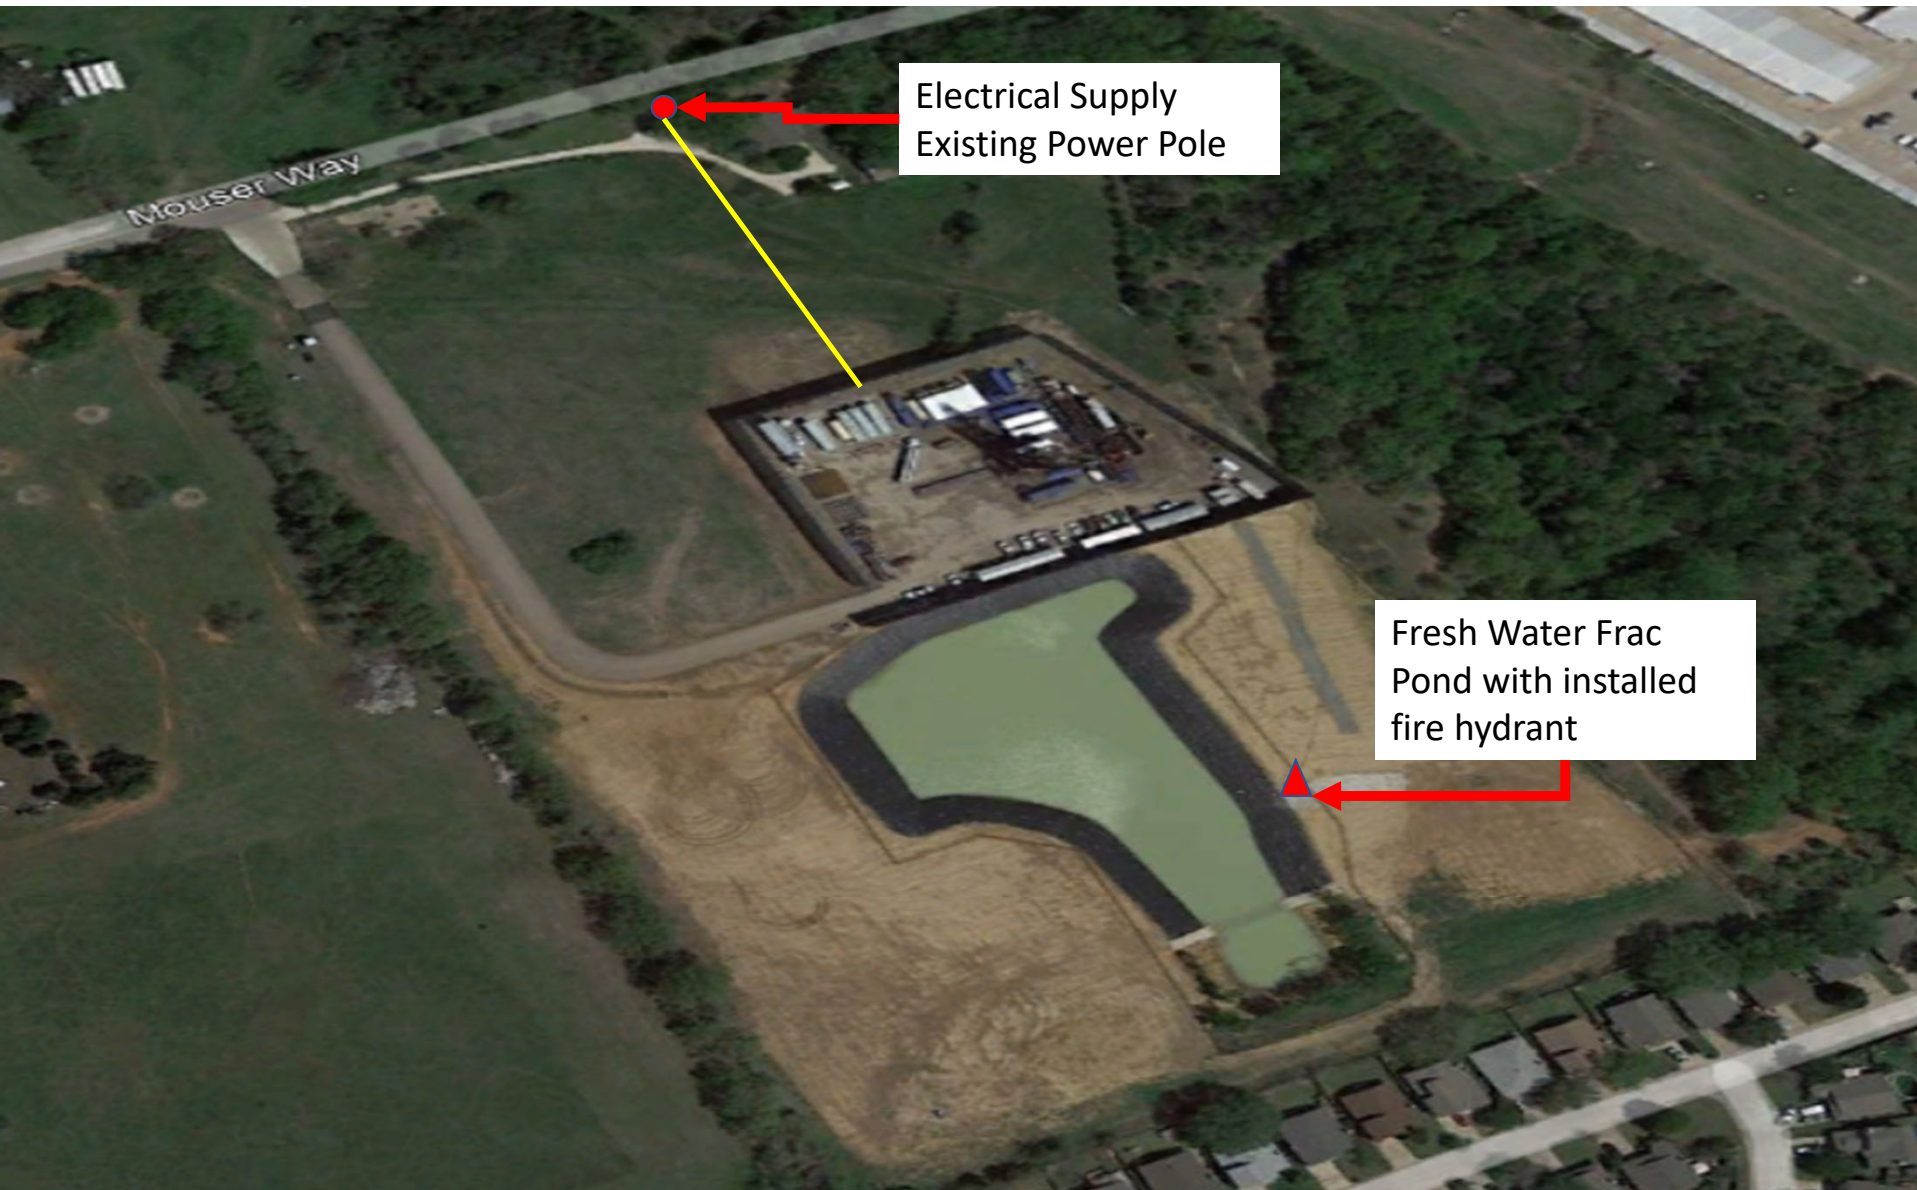

Electrical Supply
Existing Power Pole

Fresh Water Frac
Pond with installed
fire hydrant

OVERSTREET DRILL SITE
GHA BARNETT, LLC.
DRILL SITE PLAN
MANSFIELD, TEXAS

PROJECT TITLE:
OVERSTREET DRILL SITE
GHA BARNETT, LLC.

m|ma
4014 W. Loop West, Suite 100, Houston, TX 77067
Phone: 281-460-1000
Fax: 281-460-1001
www.mma.com

PROJECT NUMBER: 0806-00-03
PROJECT MANAGER: J. SUMPTON
DESIGNED BY: M. YOUNG
CHECKED BY: A. GARDNER
SCALE: AS SHOWN

REV. DATE DESCRIPTION BY

SHEET NO. 1

COPYRIGHT © 2012 MMA, INC.

